


CONSULTANT

ISSUED

Date	Issued for
2019-02-10	ISSUED FOR CLIENT REVIEW
2019-02-29	ISSUED FOR CLIENT REVIEW
2020-02-24	ISSUED FOR DEVELOPMENT PERMIT
2021-01-24	ISSUED FOR CLIENT REVIEW

REVISIONS

#	Date	Remarks
---	------	---------

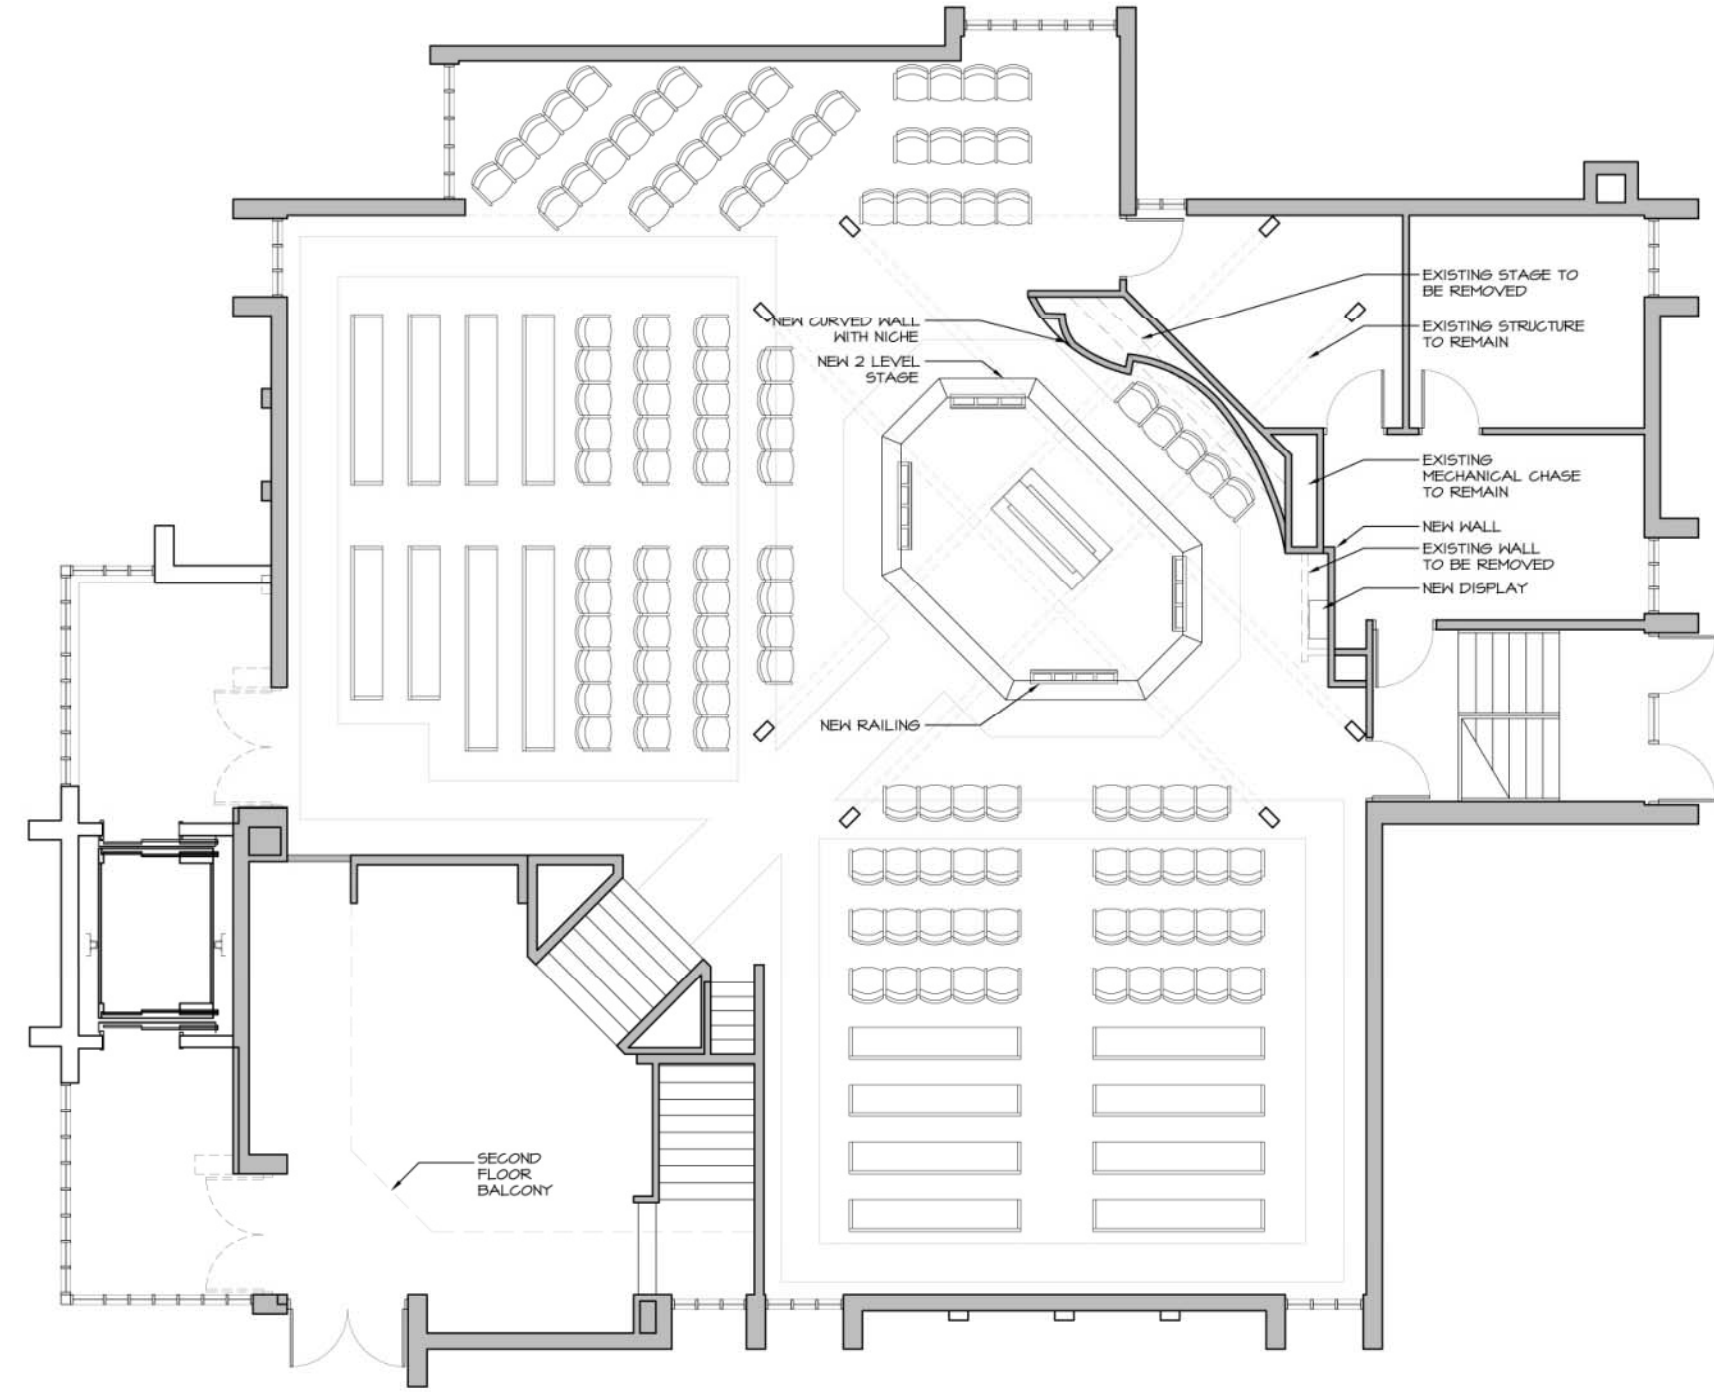

**PROPOSED MAIN FLOOR PLAN**  
A2.2.1 SCALE: 1:50

ISSUED FOR DP

**ST. LAURENCE**  
ANGELICAN CHURCH  
CHURCH ADDITION

1000 LAURENCE AVENUE SW, CALGARY, ALBERTA

Drawn:	CZ	Designed:	CZ
Checked:	CG	Checked:	GC
Project Number	11 10 055		

NOT FOR CONSTRUCTION

MAIN FLOOR PLANS

**A2.2.1**


CONSULTANT

ISSUED

Date	Issued for
2011-02-10	ISSUED FOR CLIENT REVIEW
2010-12-23	ISSUED FOR CLIENT REVIEW
2010-12-24	ISSUED FOR DEVELOPMENT PERMIT
2011-01-24	ISSUED FOR CLIENT REVIEW

REVISIONS

#	Date	Remarks
---	------	---------

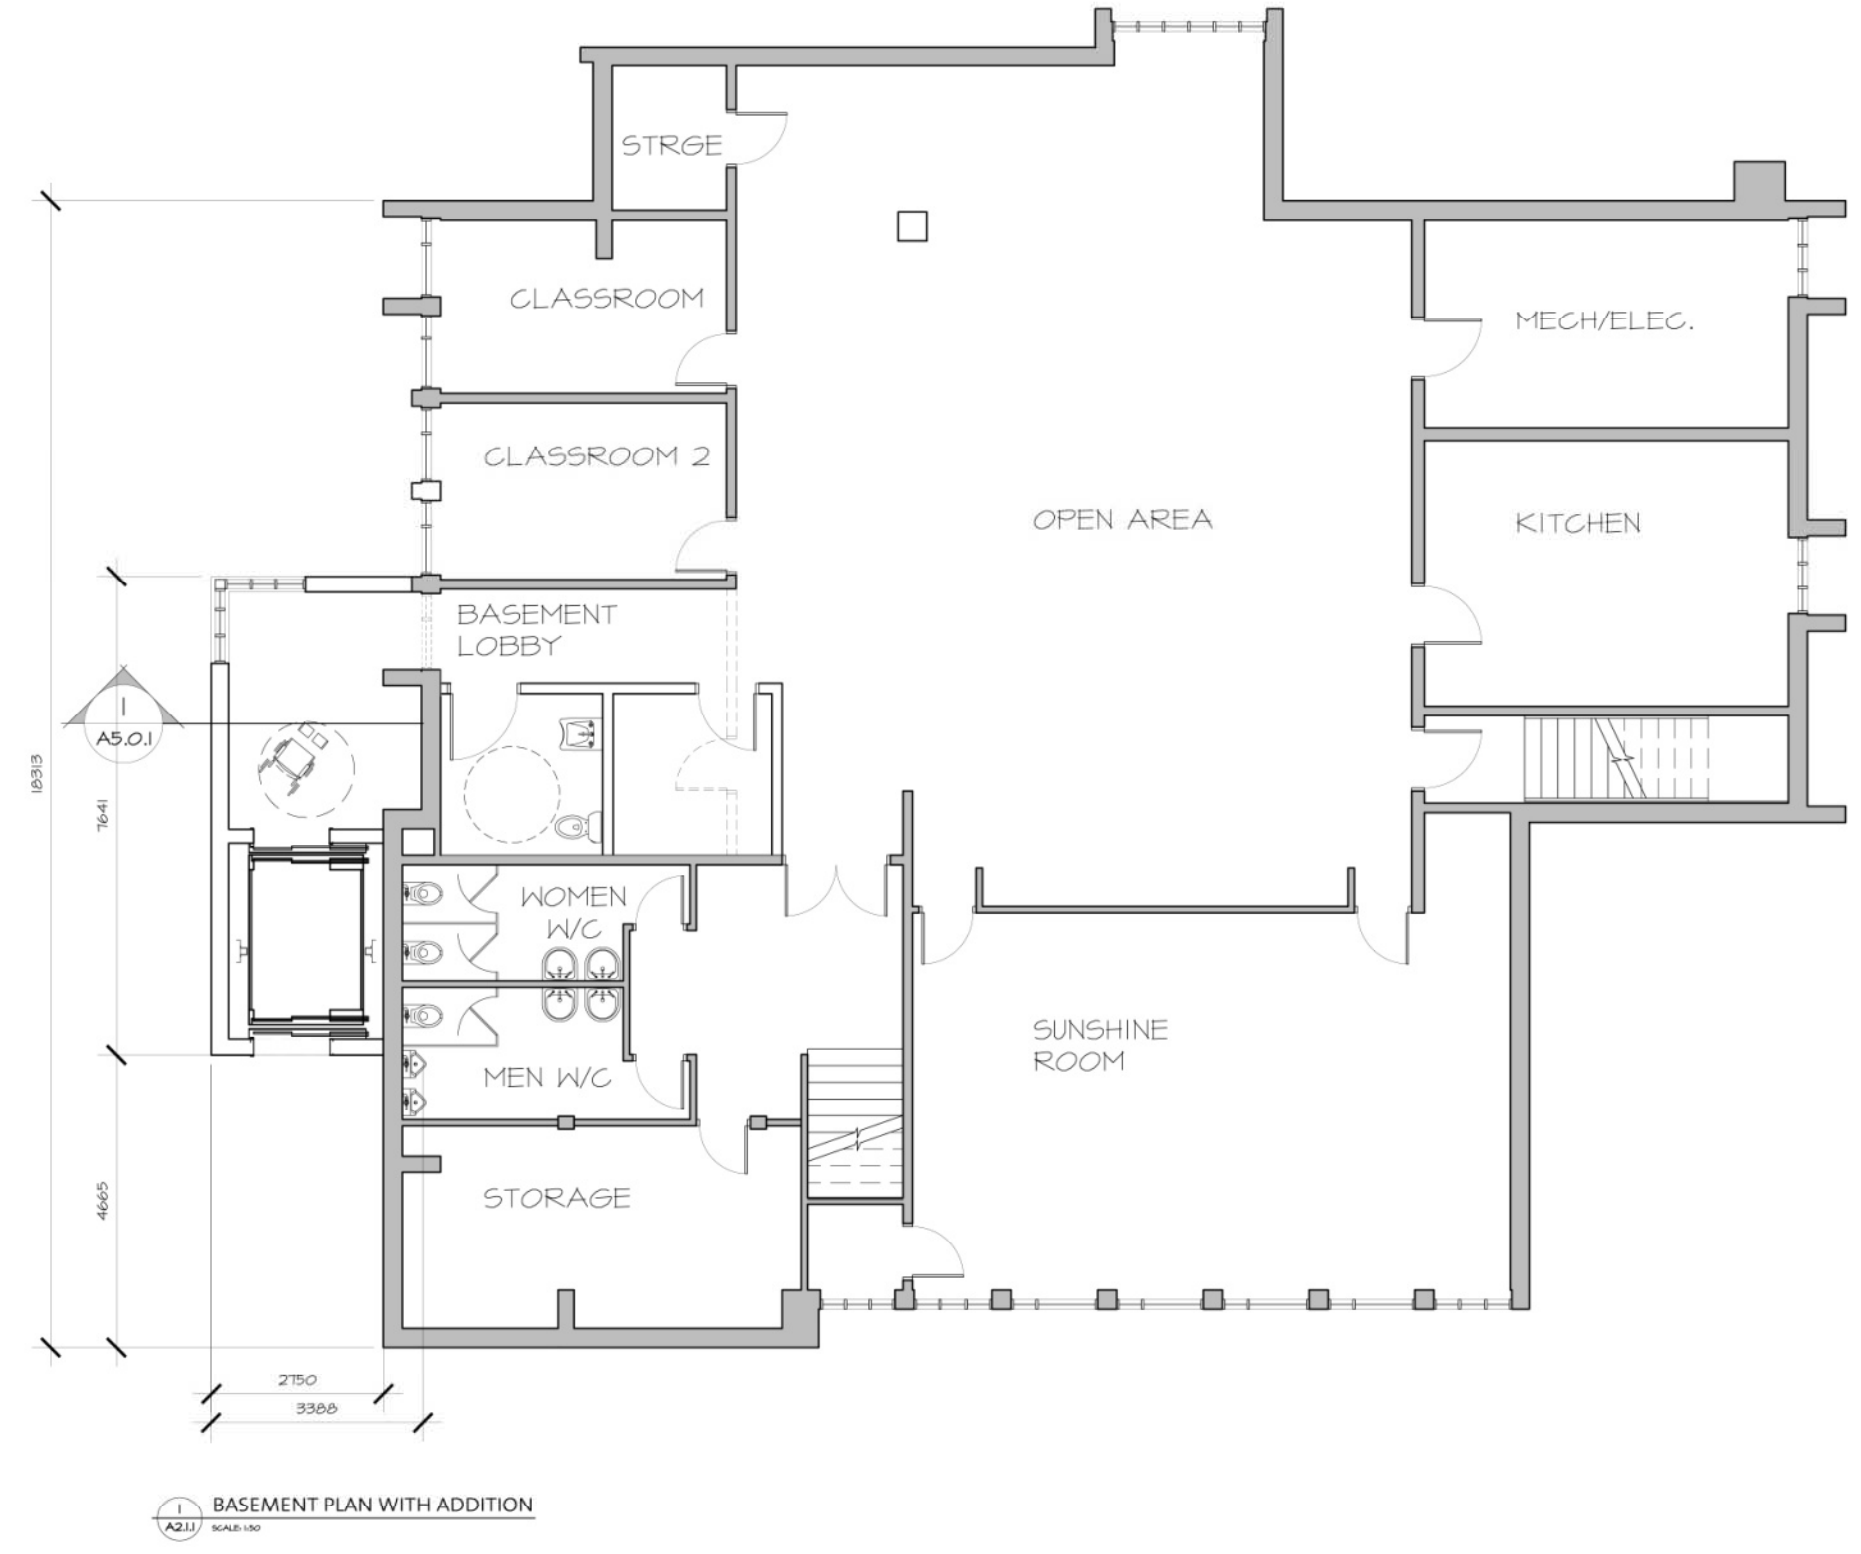

**A2.1.1** BASEMENT PLAN WITH ADDITION  
SCALE: 1:50

ISSUED FOR DP

**ST LAURENCE**  
ANGELICAN CHURCH  
CHURCH ADDITION  
3800 LAURENCE BLVD SW, CALGARY, ALBERTA

Drawn:	CG	Designed:	FC
Checked:	CG	Checked:	GC
Project Number	11 10 055		

NOT FOR CONSTRUCTION

BASEMENT FLOOR PLANS

**A2.1.1**





CONSULTANT

ISSUED

Date	Issued for
2011-02-10	ISSUED FOR CLIENT REVIEW
2010-02-23	ISSUED FOR CLIENT REVIEW
2010-02-24	ISSUED FOR DEVELOPMENT PERMIT
2011-01-24	ISSUED FOR CLIENT REVIEW

REVISIONS

#	Date	Remarks
---	------	---------

ISSUED FOR DP

**ST LAURENCE**  
ANGELICAN CHURCH  
CHURCH ADDITION

1000 UNIVERSITY DRIVE, CALGARY, ALBERTA

Drawn:	CG	Designed:	FC
Checked:	CG	Checked:	GC
Project Number	11 10 055		

OMICRON ARCHITECTURE ENGINEERING LTD.

This drawing is a copyright instrument of service and remains the property of the Consultant. No information shown on this drawing is to be reproduced or transmitted in any form or by any means, electronic, mechanical, photocopying, recording, or by any information storage and retrieval system, without the prior written permission of the Consultant. The Consultant shall not be held responsible for all dimensions, details, and omissions.

Not to be used for construction purposes without the written consent of the Consultant. All work shall conform to the latest edition of local building codes, construction codes and local ordinances. Drawing sheet numbers are printed as follows:  
A = Arch/Structural  
E = Electrical  
FP = Fire Protection  
ME = Mechanical/Electrical/HVAC  
P = Plumbing  
C = Civil

PROPOSED INTERIOR RENDERING OPTION WITH OUT RAILING

